


ELECTRICAL SCHEDULE	
CODE	DESCRIPTION
	Downlight
	Single Way Switch
	Exhaust Fan. 3-in-1 heat lamp TBC
	Double GPO
	Single GPO
	Cooktop Switch
	Two Way Switch
	Batten Holder
	Alarm Sensor
	Alarm Control Pad
	Intercom Screen
	AC Control Pad
	Data
	TV
	Motorized Roller Blinds

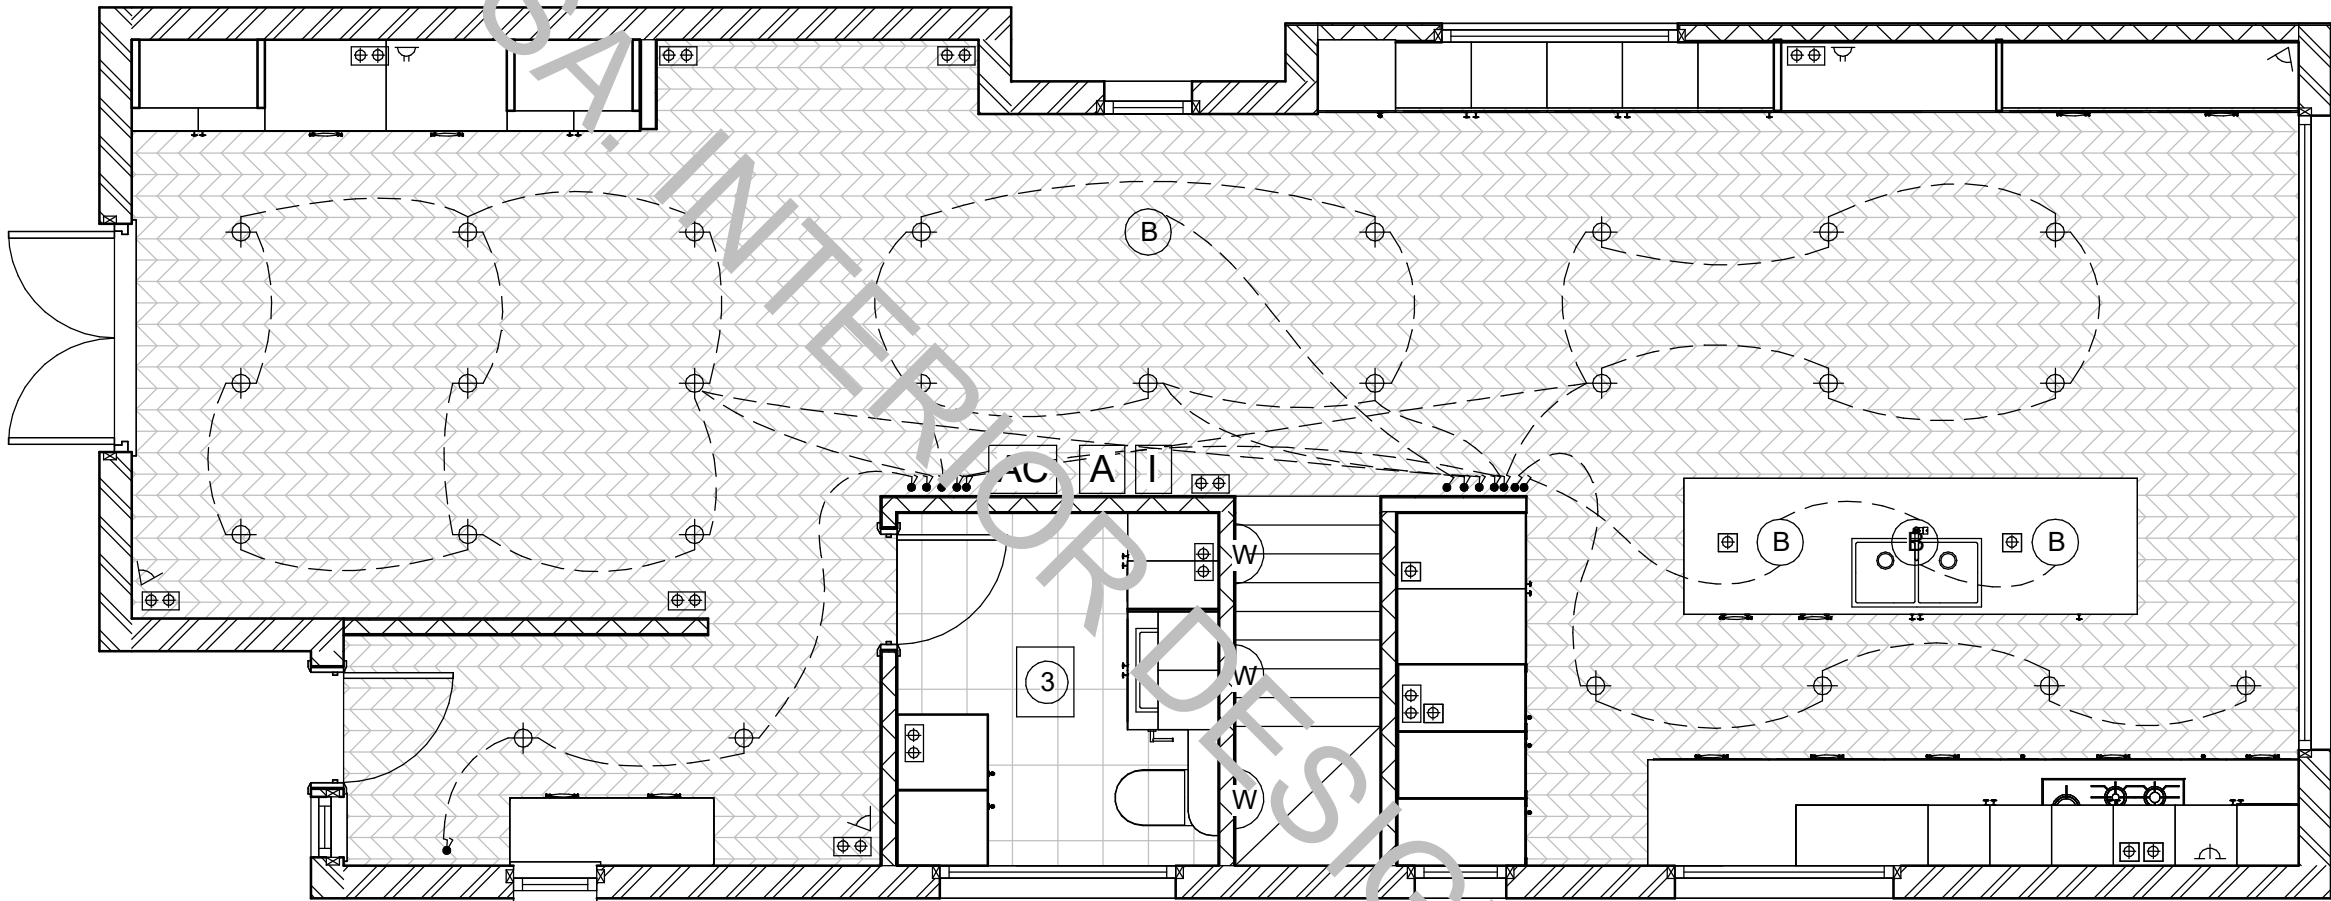

Revisions			Approver	Do not scale drawings. Use figured dimensions only. Check and verify levels and dimensions on site prior to commencement of any work, the preparation of drawings or the fabrication of components. This drawing is copyright and can not be reproduced without written consent.	Client	 SARA - ANN INTERIOR DESIGN	Scale	1 : 50	Drawing Title GF Electrical Plan		Issue 01		
No	Date	Description	Ver. App'd				Date	23.12.24					
01	23.10.24	CONCEPT ELECTRICAL	SR										
							Drawn by	Sara Rhodes	Drawing Status PRESENTATION DRAWINGS NOT FOR CONSTRUCTION	Project number Q018	Page No. A101		